


| RevNo | Revision note       | Date     | Signature | Checked |
|-------|---------------------|----------|-----------|---------|
| A     | PROPOSED REDESIGNED | 19.01.21 | RM        | AN      |

- ### FIRE KEY
- SMOKE DETECTOR
  - HEAT DETECTOR
  - FIRE EXT
  - EMERGENCY LIGHT
  - FIRE ALARM
  - BEACON
  - BREAK GLASS POINT
  - FIRE BLANKET
  - H<sub>2</sub>O EXTINGUISHER
  - CO<sub>2</sub> EXTINGUISHER
  - HALF HR FIRE DOOR

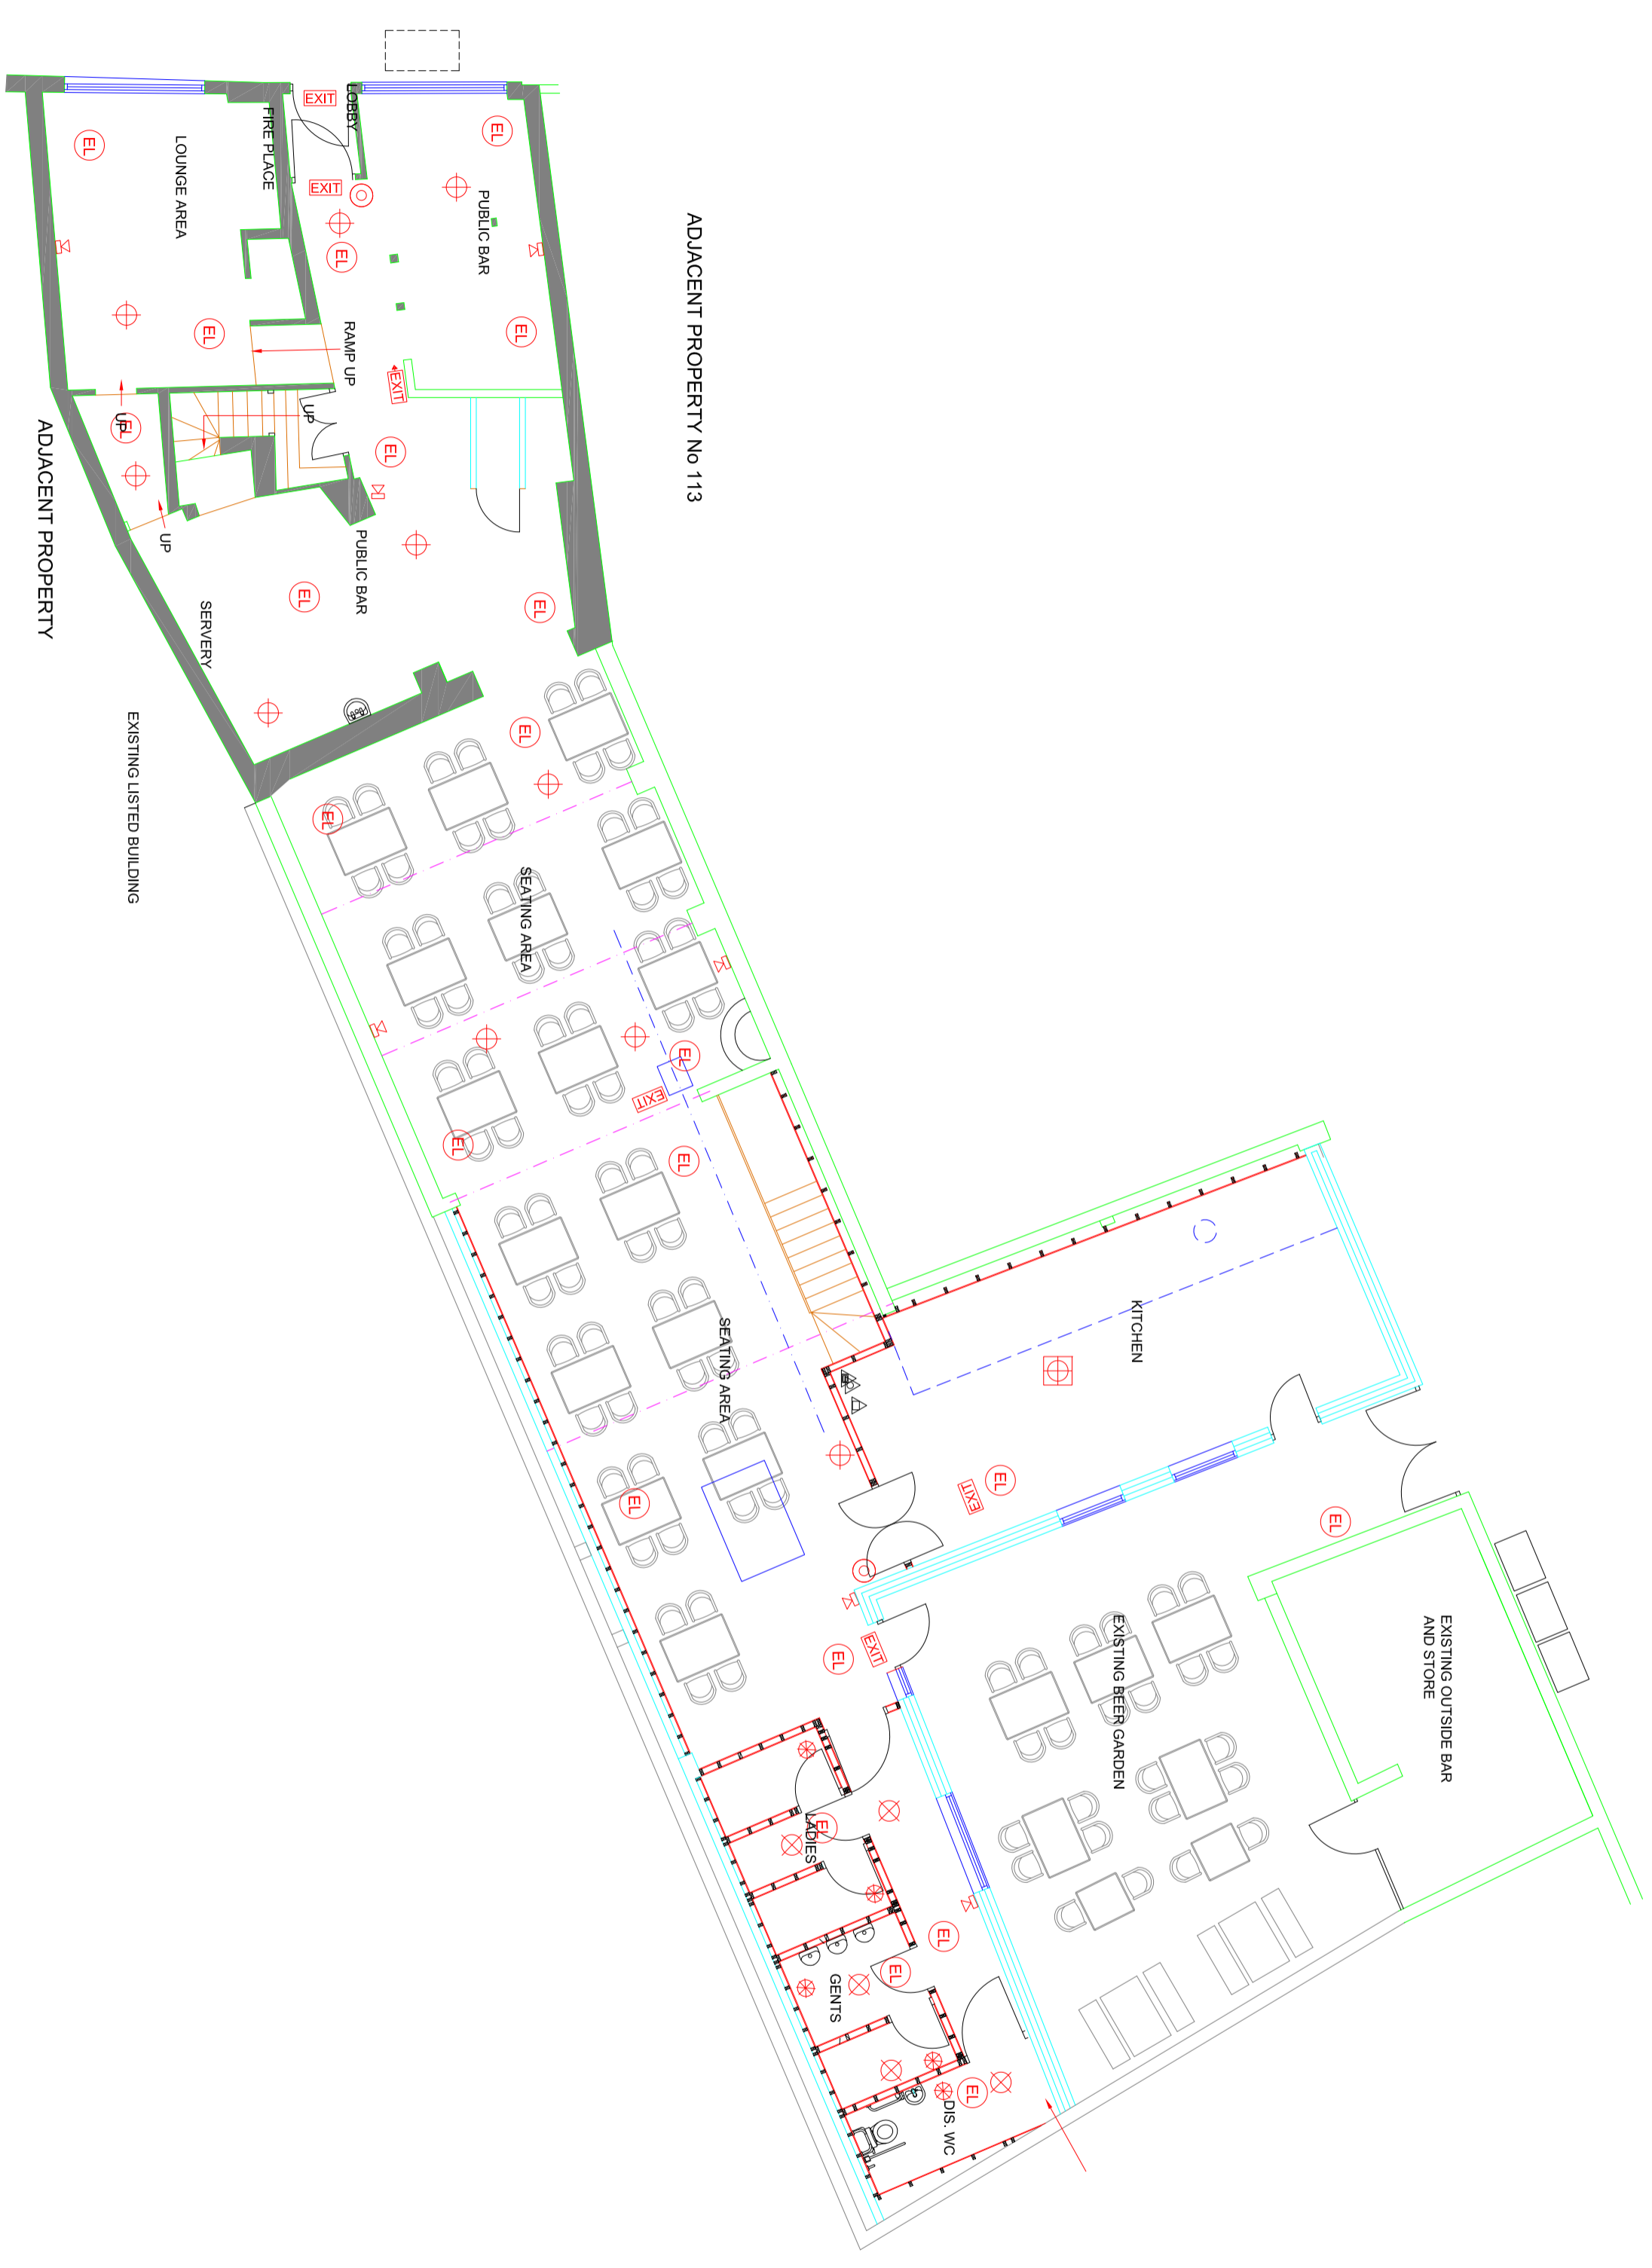

GROUND FLOOR PLAN AS PROPOSED



|  |                         |                       |
|--|-------------------------|-----------------------|
| <b>Consultant</b><br><br>AMA UK CONSULTANCY LTD<br>Civil/Structural and Engineering Consultants<br>11 Finsign Business Centre, Westwood Way,<br>Westwood Business Park, Coventry, CV4 8JA<br>Tel: 02476 982010, Mob: 07852125530<br>info@ama-consultancy.com |                         |                       |
| <b>Address</b> 114 GOSFORD STREET<br>COVENTRY<br>CV1 5DL   |                         |                       |
| <b>Title</b> GROUND FLOOR PLAN<br>FIRE STRATEGY  |                         |                       |
| <b>Drawn</b><br>RM   | <b>Checked</b><br>AN    | <b>Approved</b><br>AN |
| <b>Dwg No.</b> AMA 458-010   |                         |                       |
| <b>Scale</b><br>1:100  | <b>Date</b><br>14.05.20 | <b>Revision</b><br>A  |