


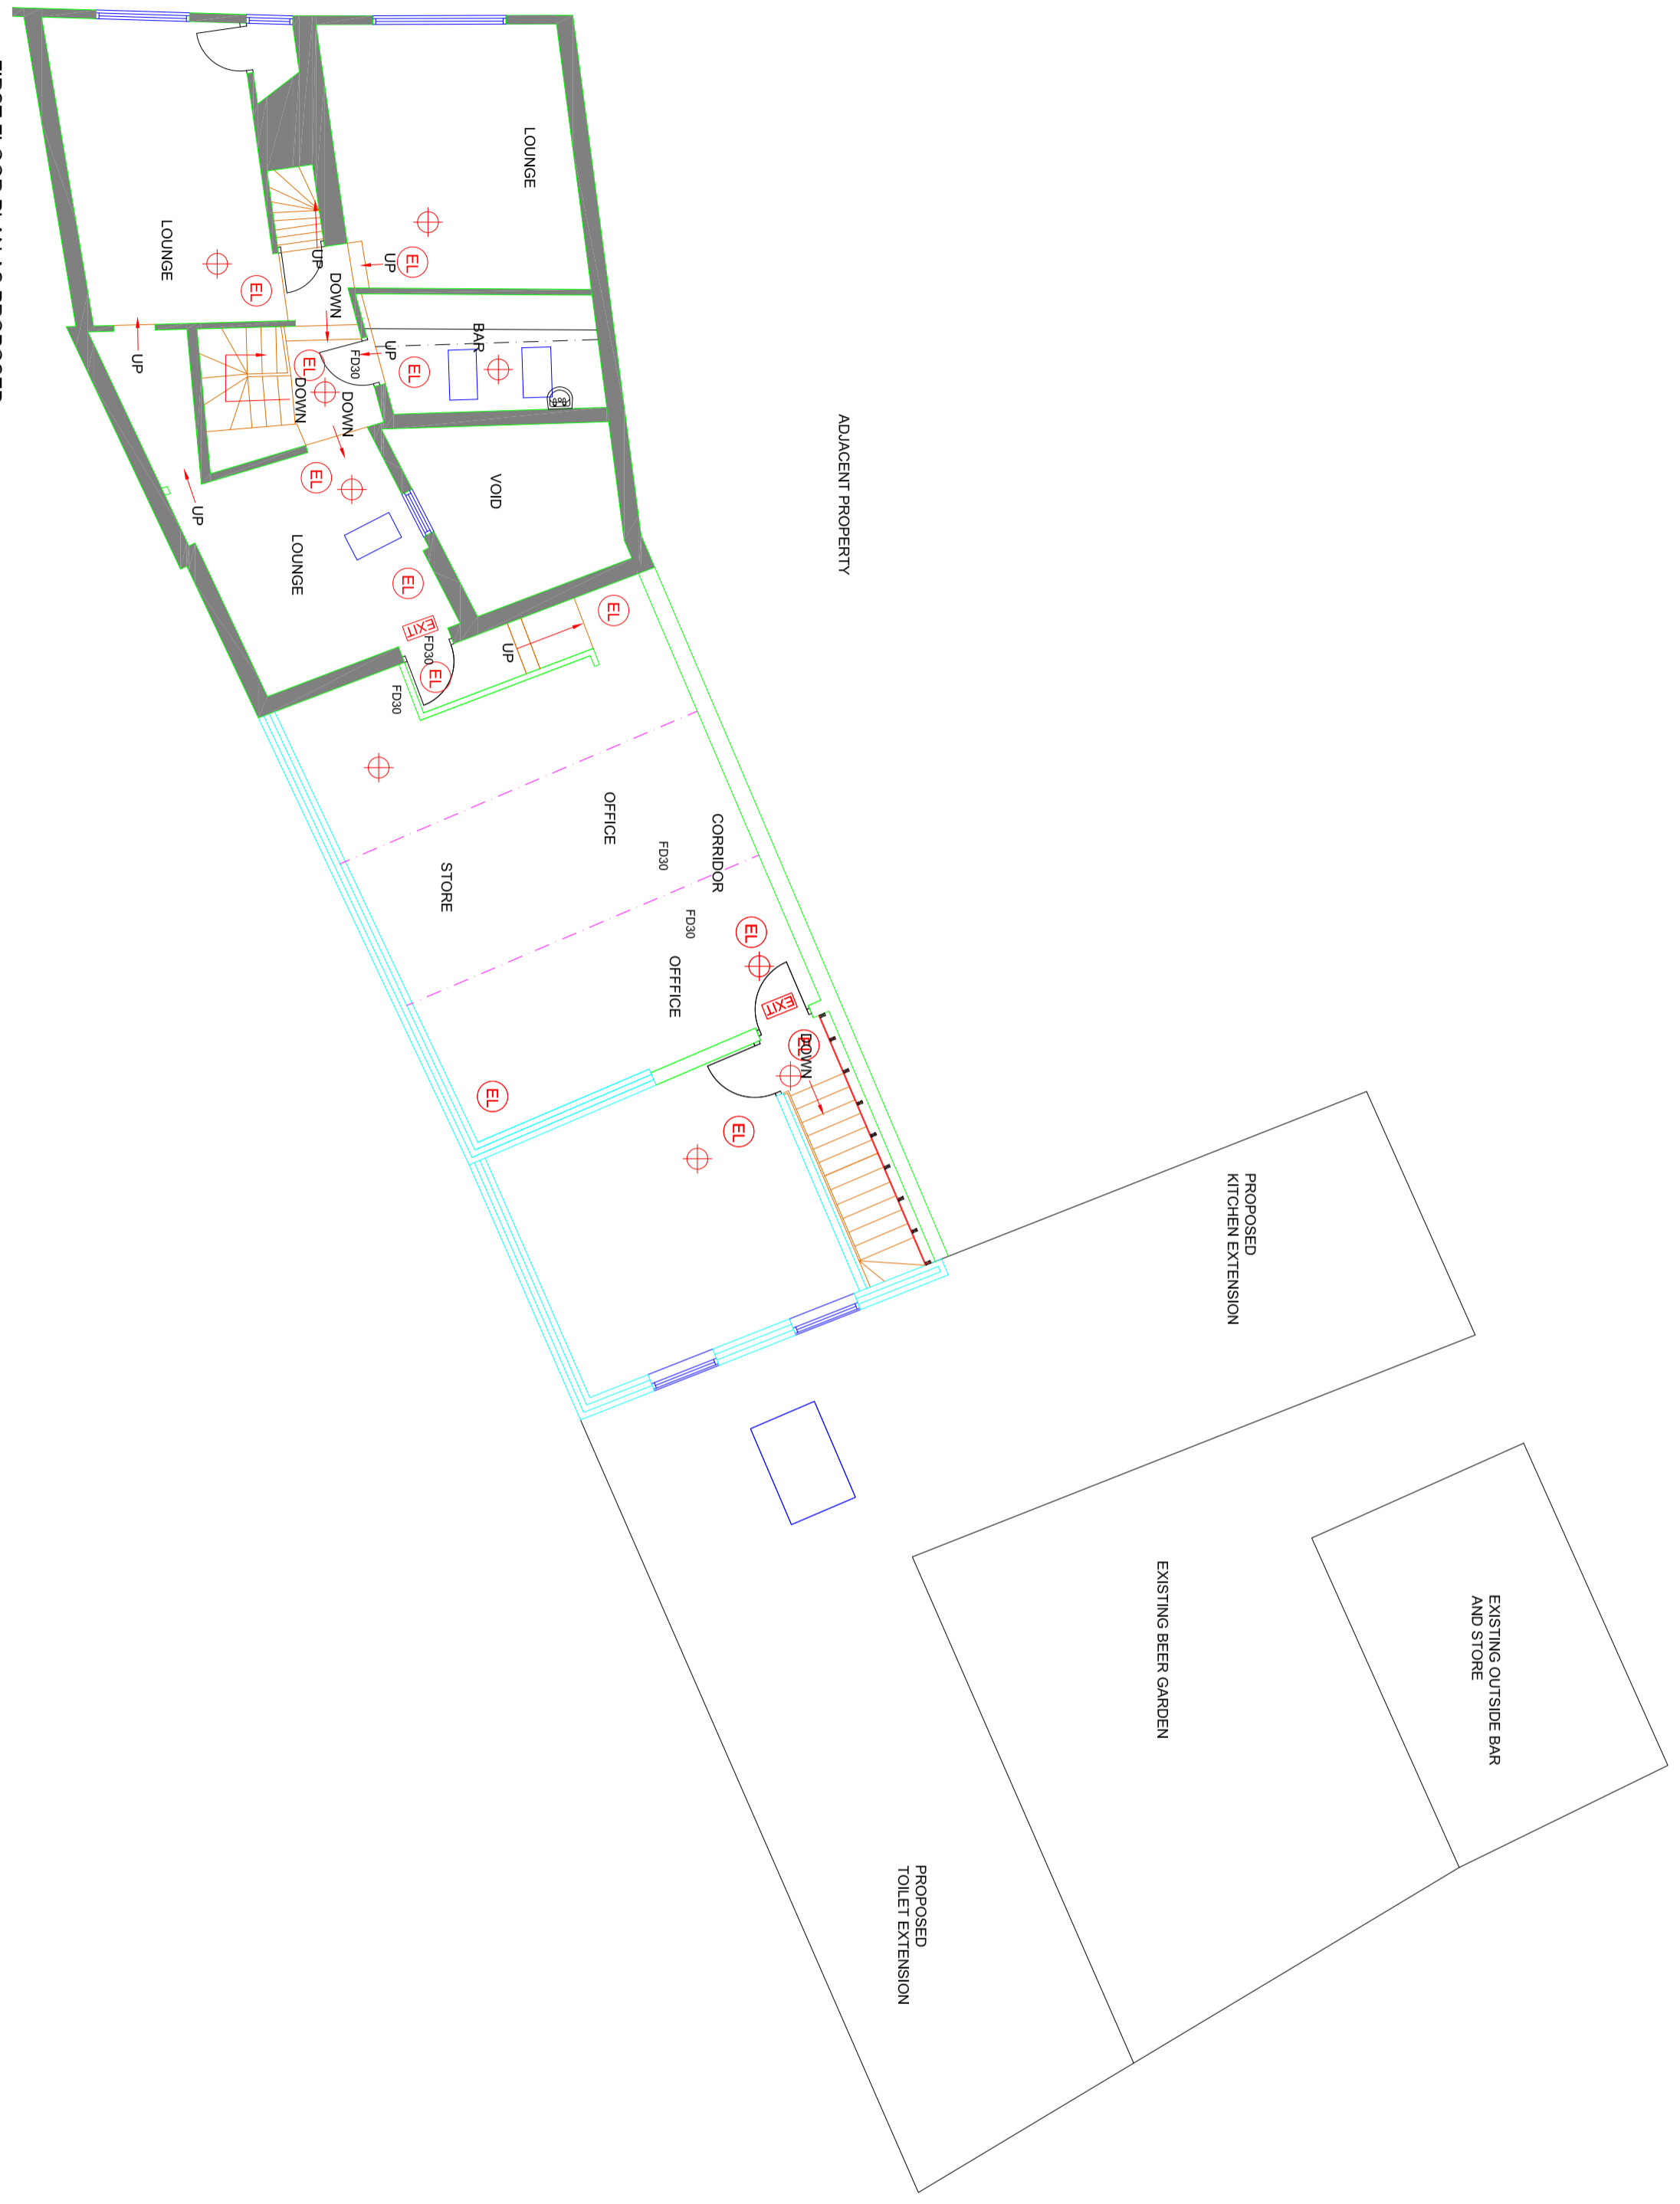



RevNo	Revision note	Date	Signature	Checked
A	PROPOSED REDESIGNED	19.01.21	RM	AN

- FIRE KEY**
-  SMOKE DETECTOR
 -  HEAT DETECTOR
 -  FIRE EXIT
 -  EMERGENCY LIGHT
 -  FIRE ALARM
 -  BEACON
 -  BREAK GLASS POINT
 -  FIRE BLANKET
 -  H₂O EXTINGUISHER
 -  CO₂ EXTINGUISHER
 -  HALF-HR FIRE DOOR



FIRST FLOOR PLAN AS PROPOSED

Consultant



AMA UK CONSULTANCY LTD
Civil/Structural and Planning Consultants
1 Finsbury Business Centre, Westwood Way,
Westwood Business Park, Coventry, CV4 8JA
Tel: 02476 982010, Mob: 07852125530
info@ama-consultancy.com

Address 114 GOSFORD STREET
COVENTRY
CV1 5DL

Title	FIRST FLOOR PLAN AS PROPOSED	
Drawn	Checked	
RM	AN	
Approved	AN	
Dwg No.	AMA 458-011	
Scale	Date	Revision
1:100	14.05.20	A