





- NOTES**
1. Do not scale. All dimensions are in millimetres unless stated otherwise.
 2. This drawing to be used only for the specific services intended.
 3. This drawing to be read in conjunction with all other relevant drawings, engineering and architectural specifications.

LEGEND

-  UNDERFLOOR HEATING AREA DESIGNED BY SPECIALIST CONTRACTOR
-  THERMOSTAT

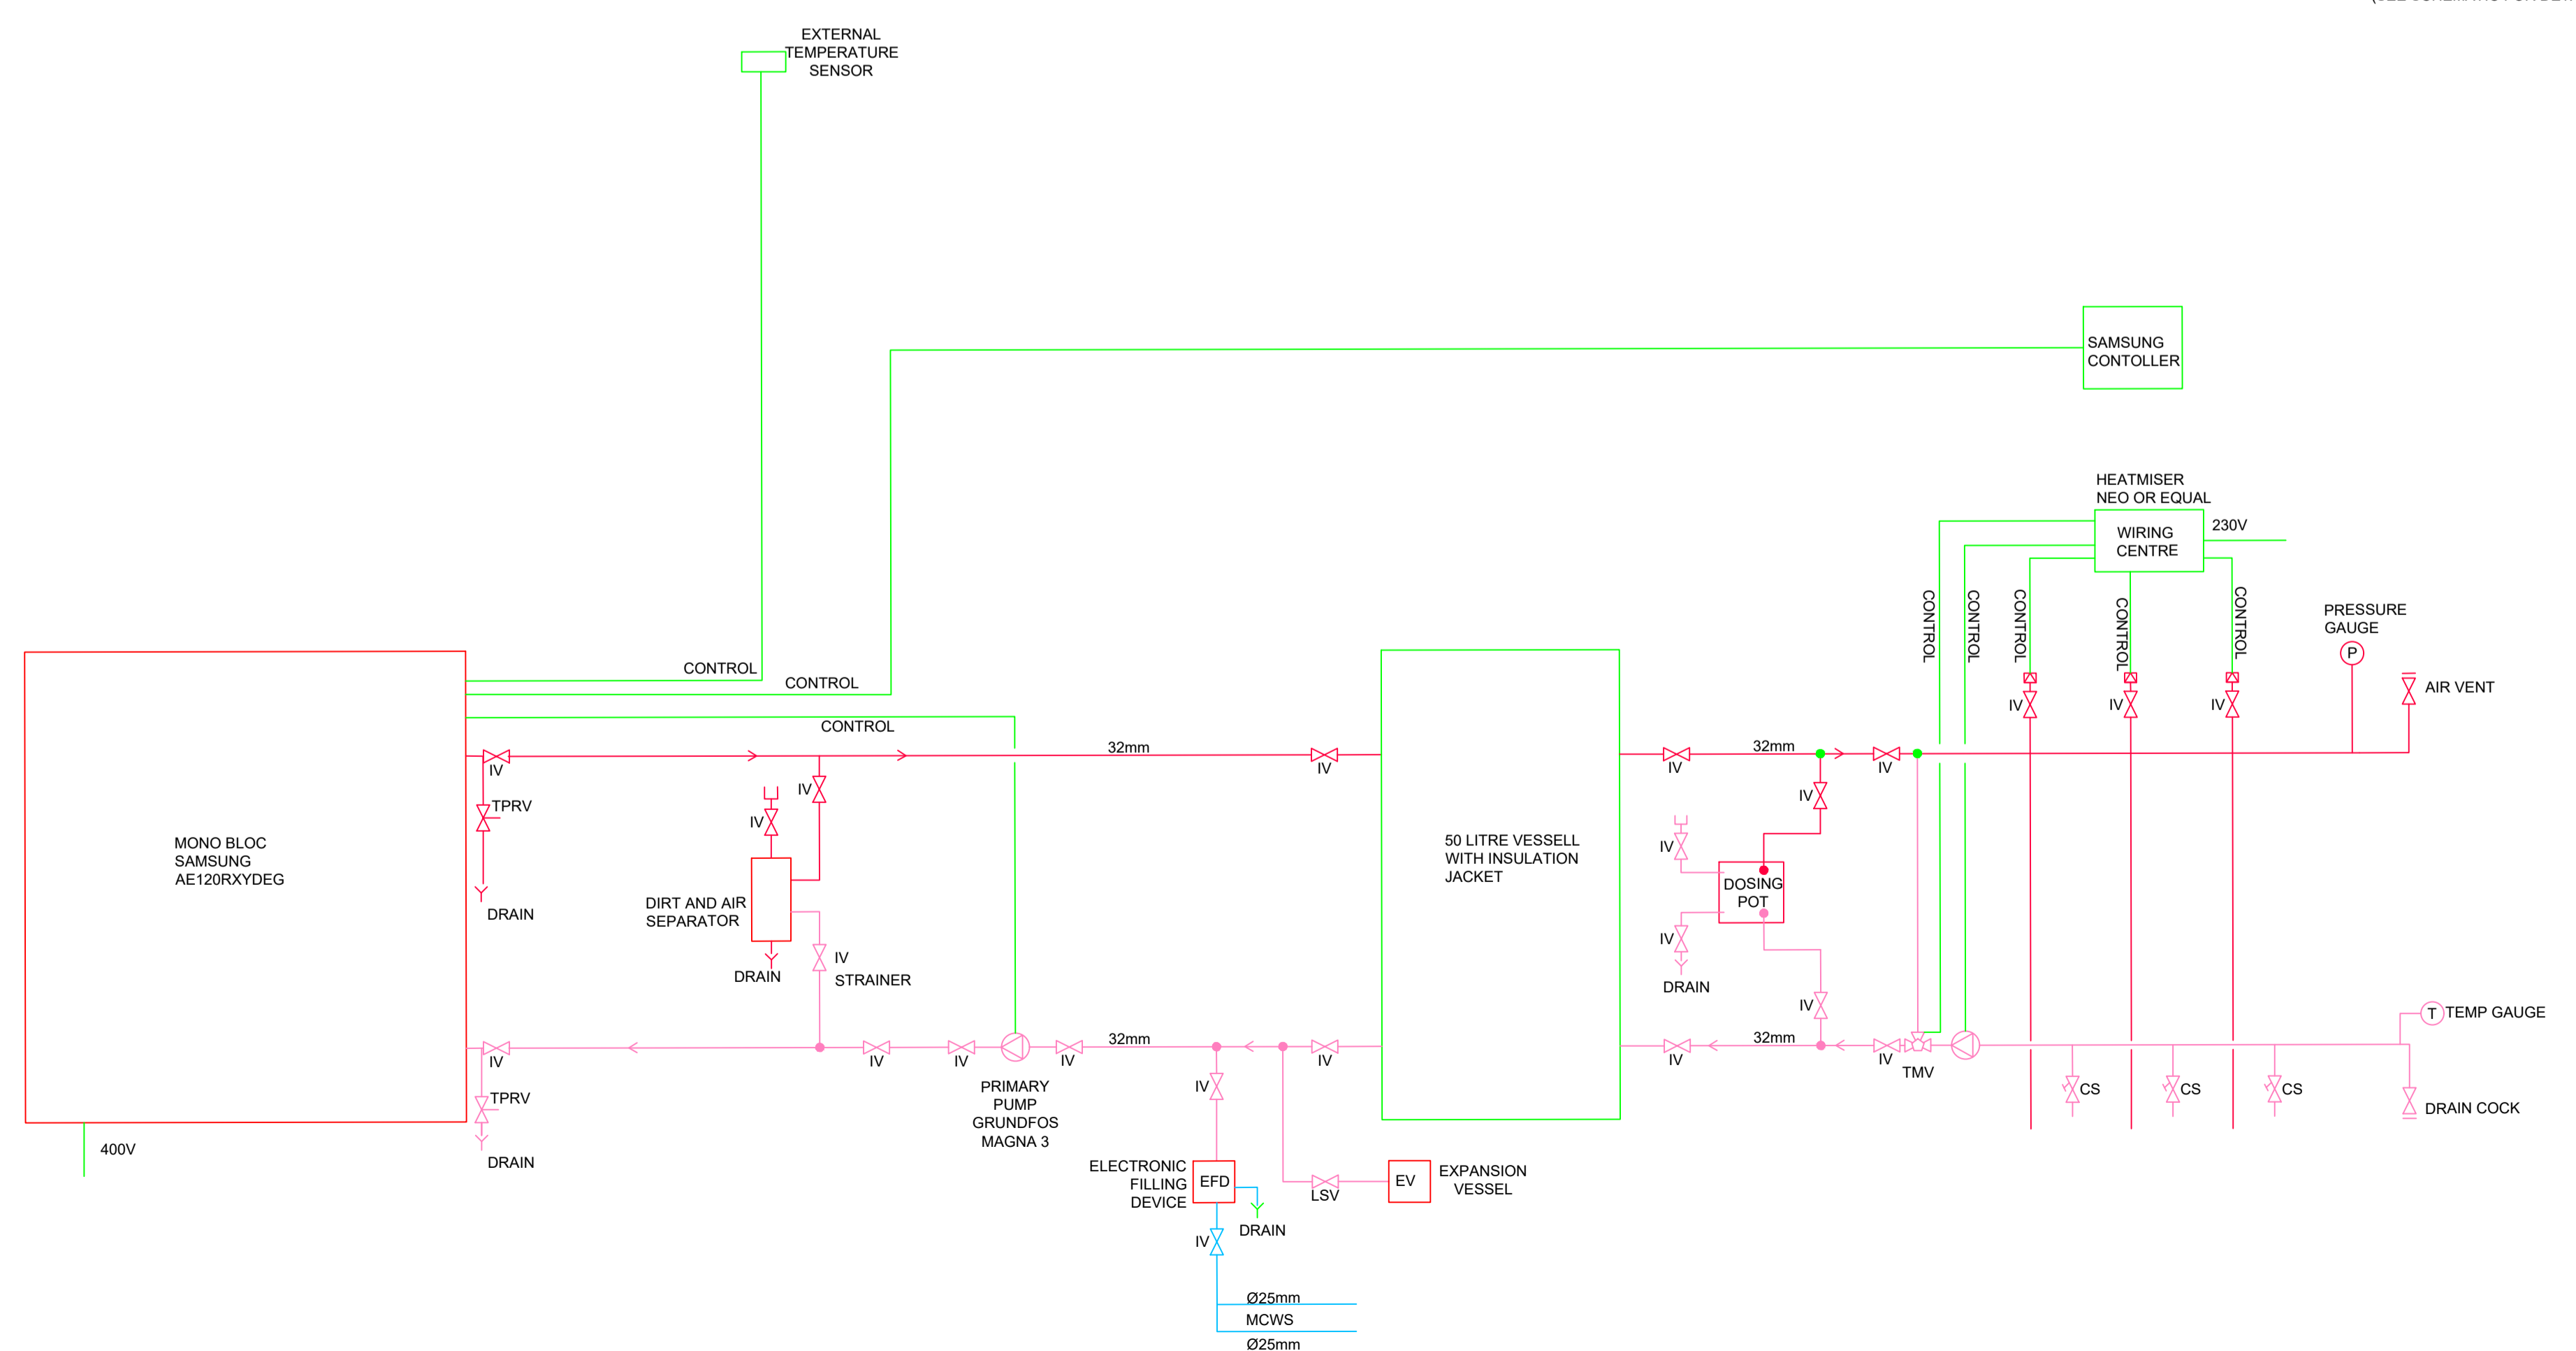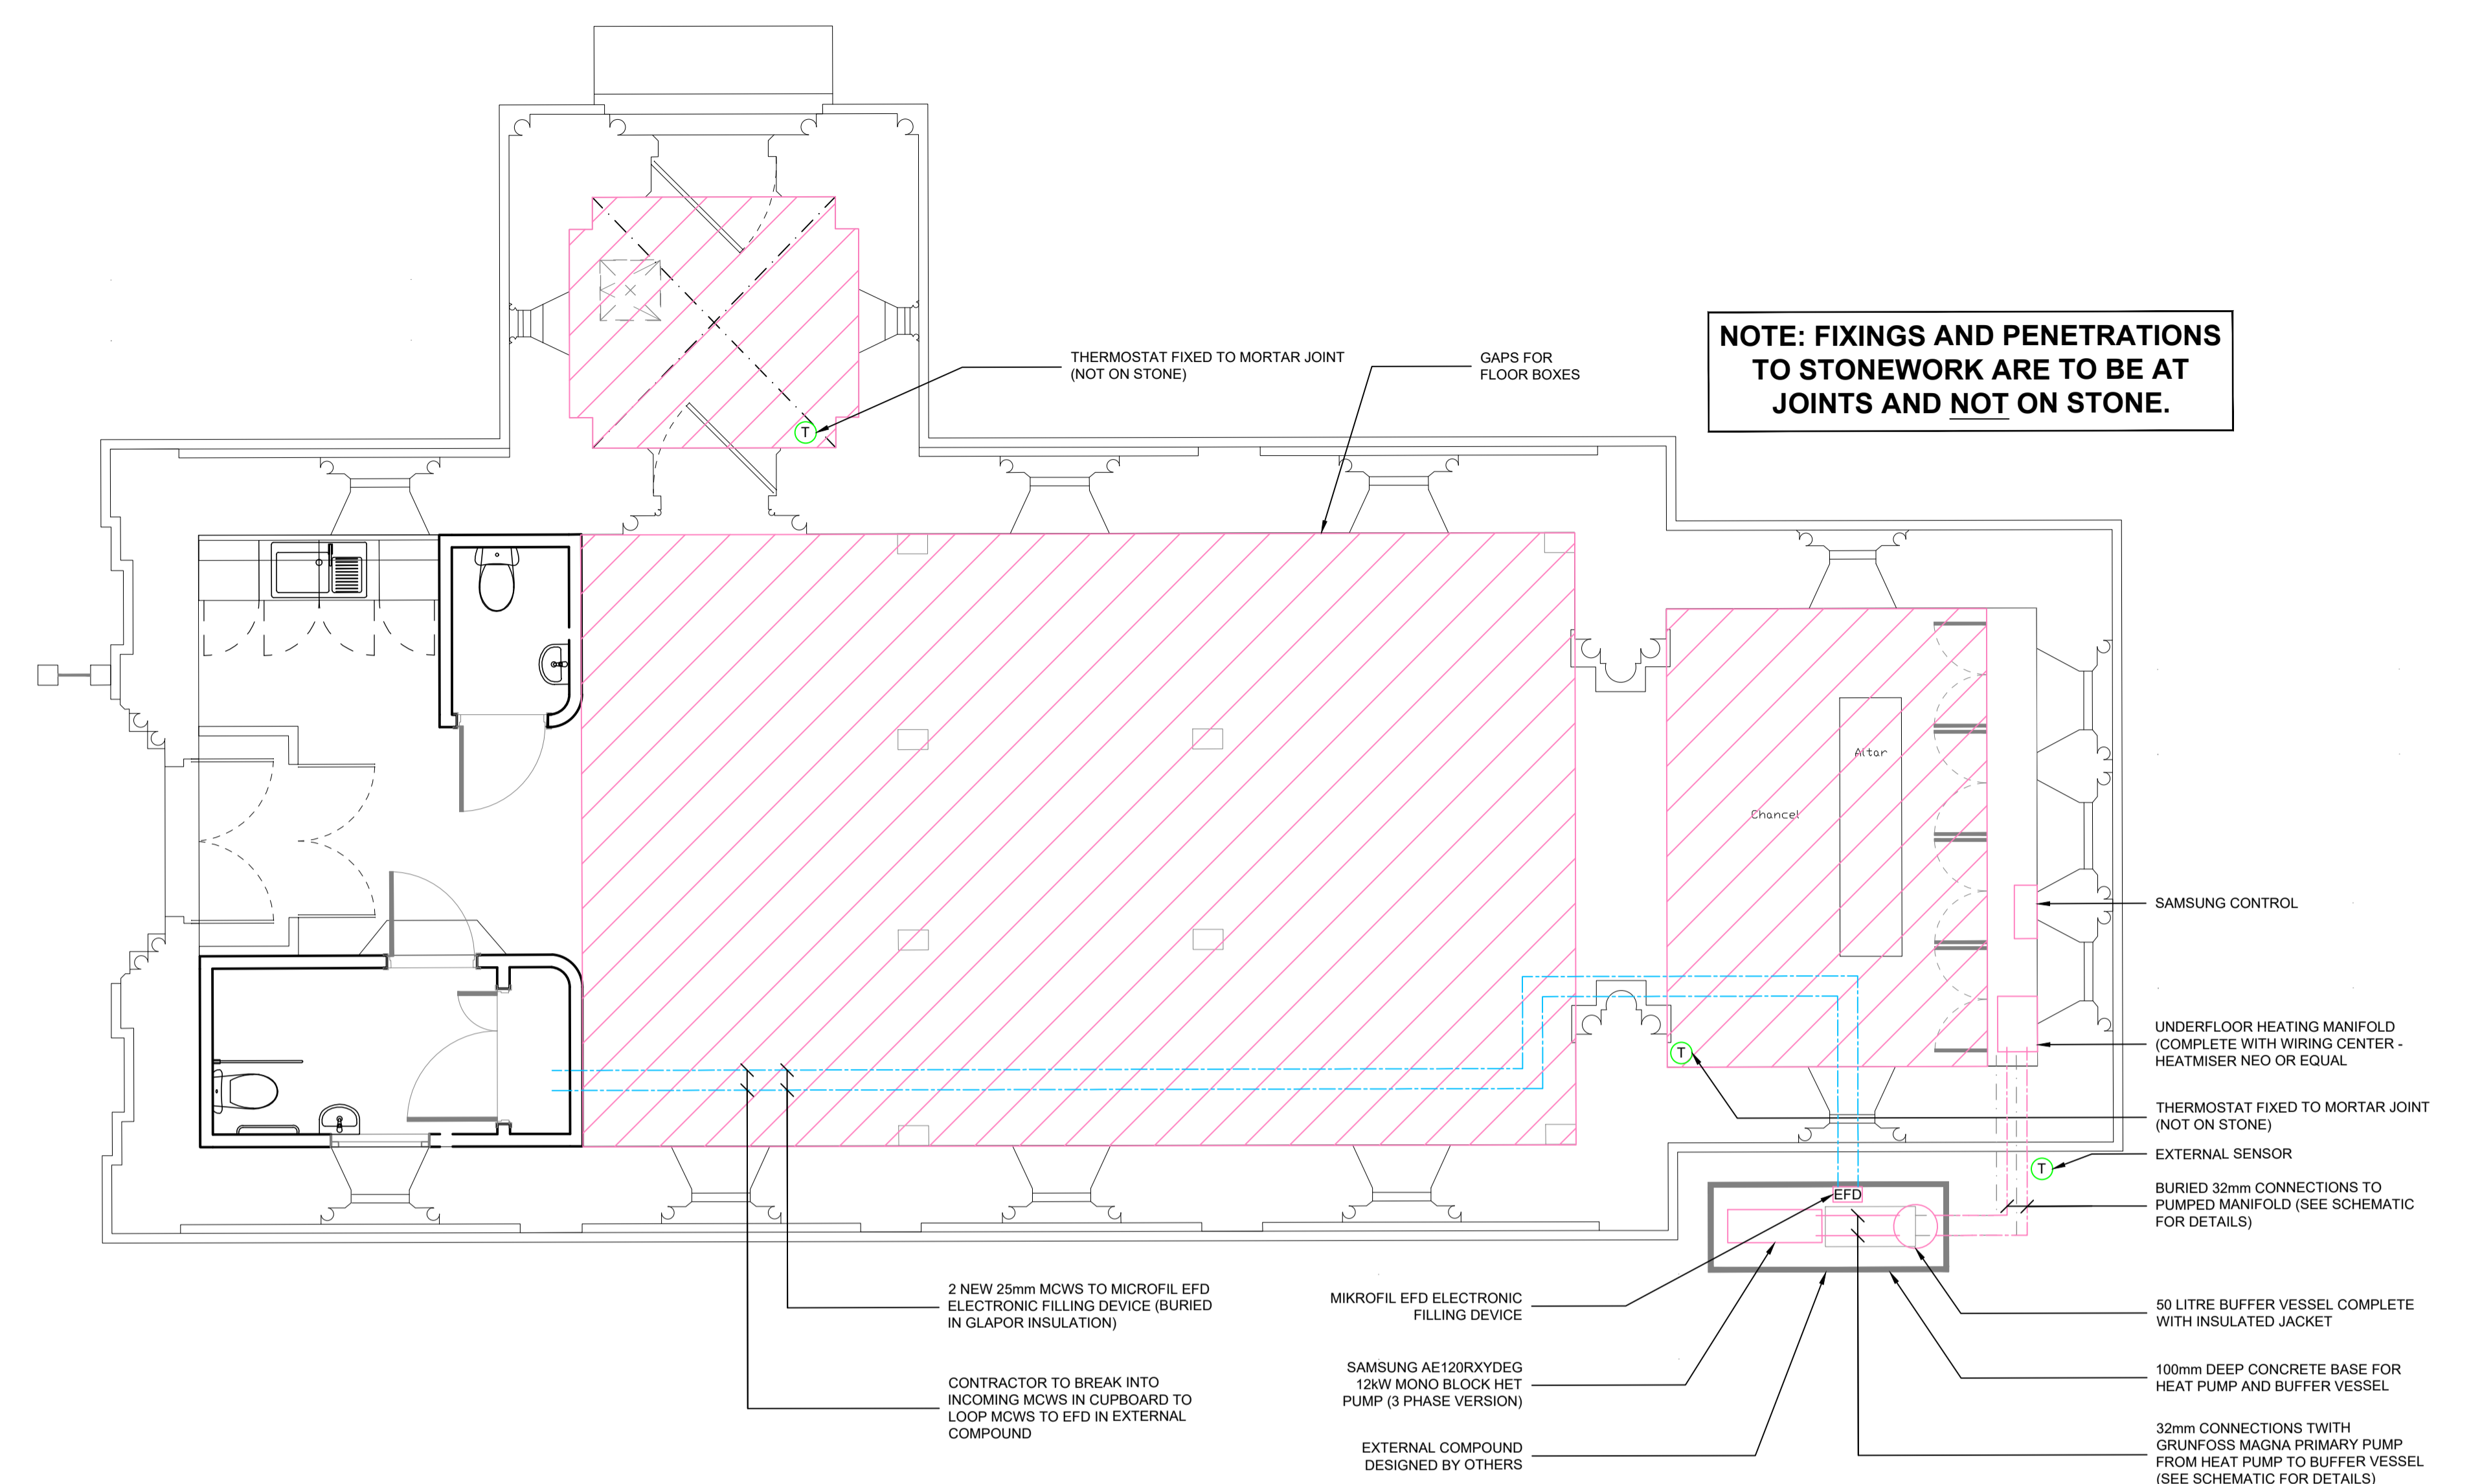

TENDER

T1	10.02.21	JC	HEATING EXTENDED UNDER ALTAR	ZT	ZT
P1	29.01.21	NM	DRAFT ISSUE	ZT	ZT
Rev	Date	Drawn	Description	Ch'k'd	App'd



Client
Coventry City Council
London Road Cemetery

Title
Anglican Chapel
Mechanical Layout

Designed	ZT	Drawn	ZT	Approved	PH
Scale at A1	1:50	CAD NAME	GBSC-M100		
Drawing No	2102-M100				Rev
					T1